


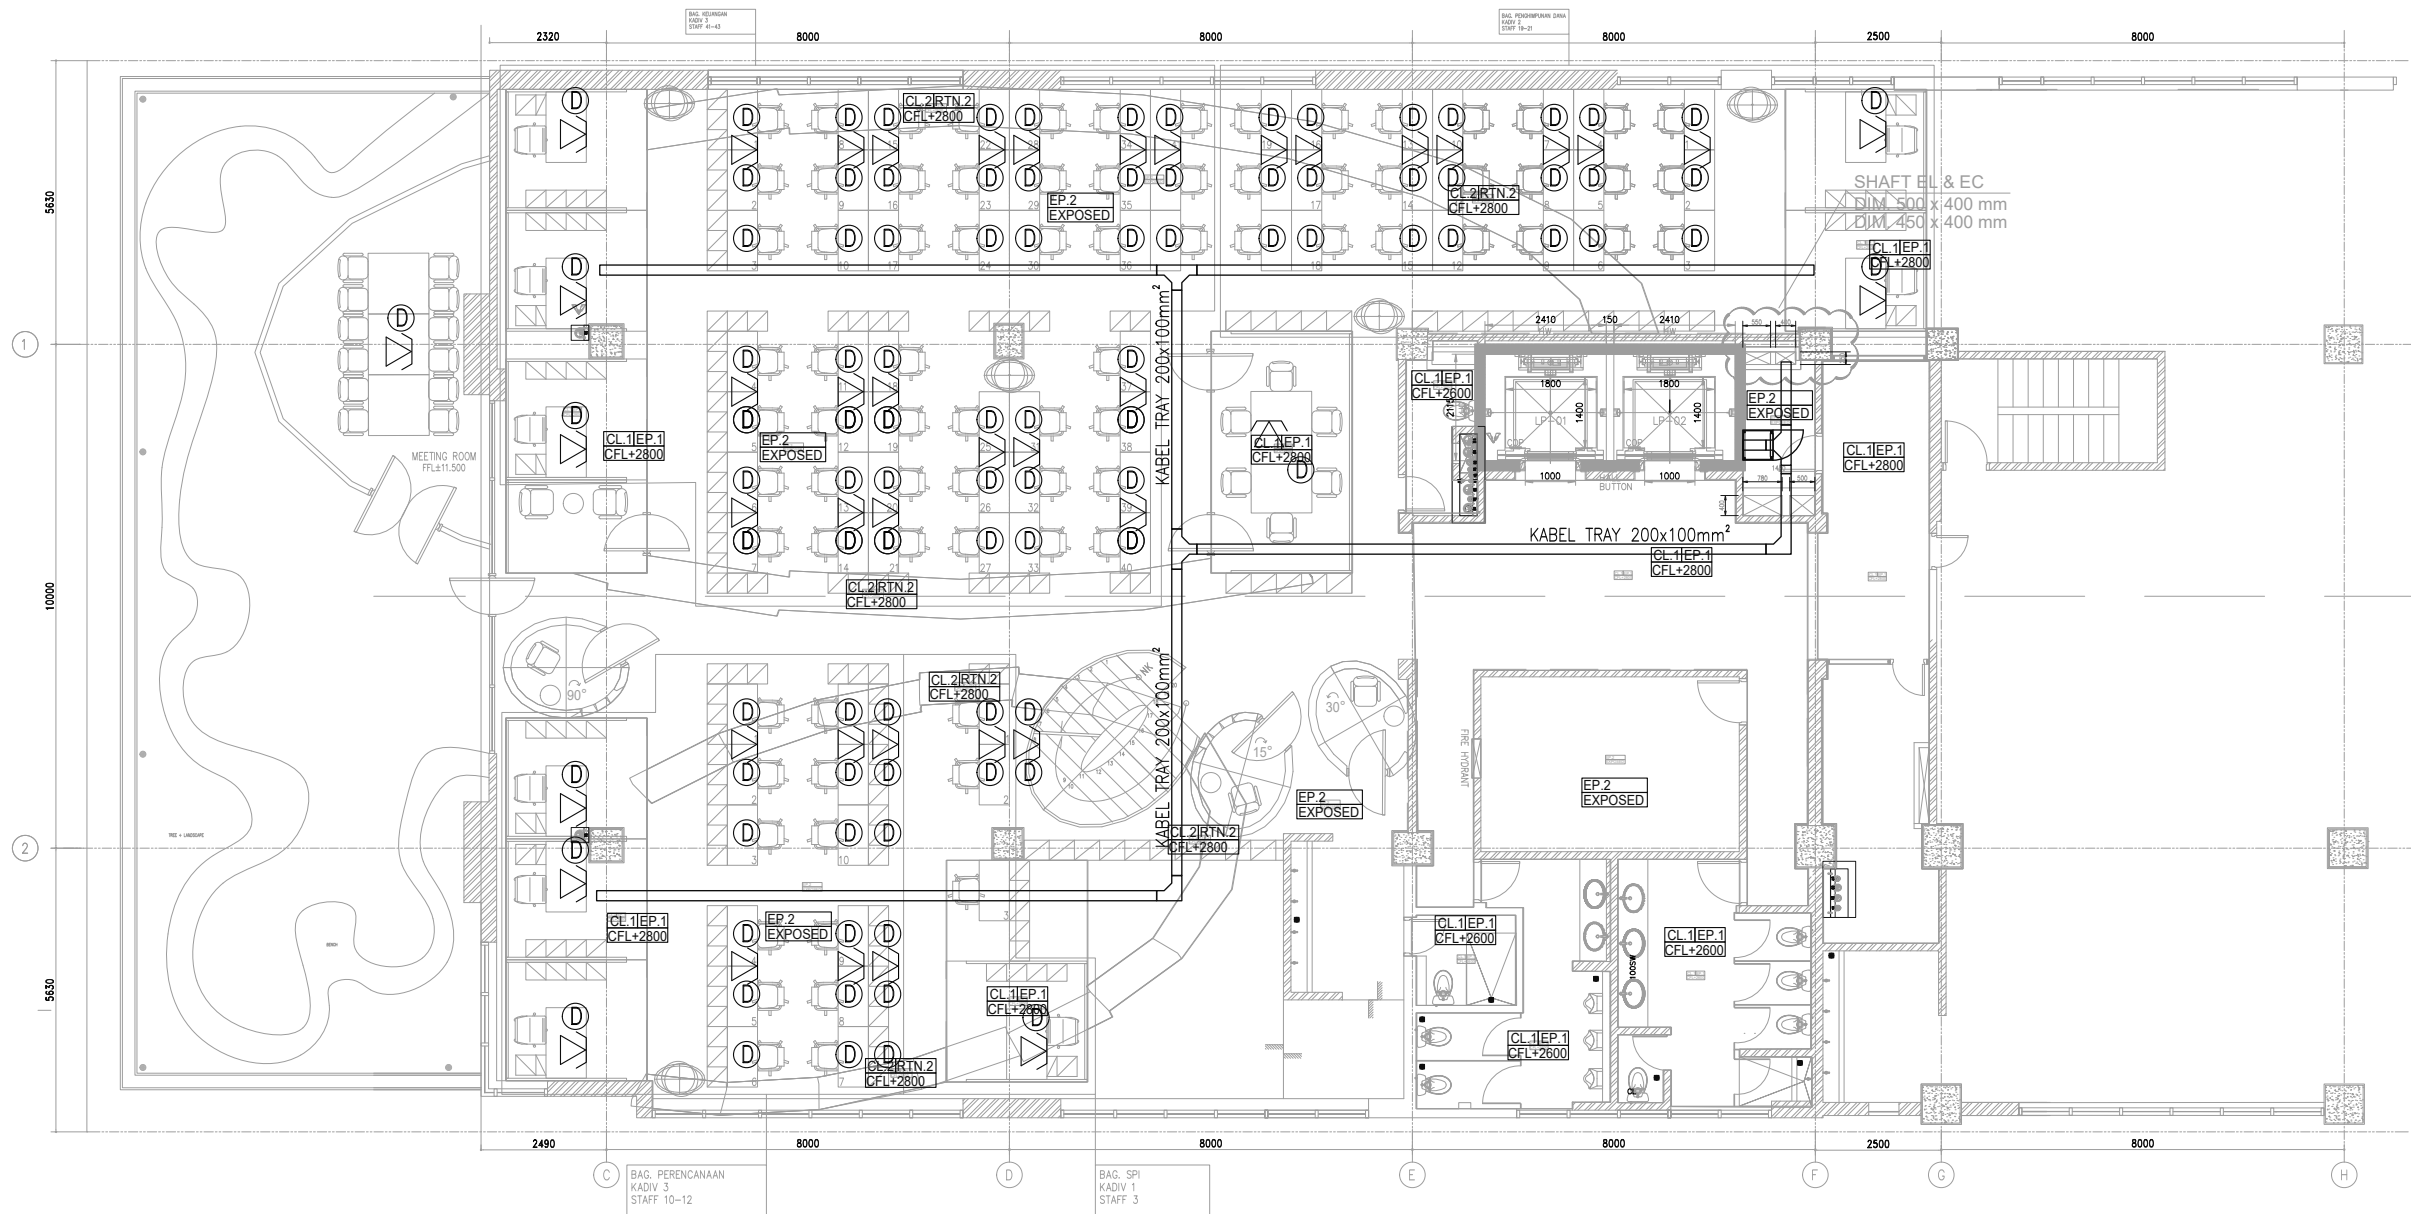



 


KETERANGAN :

- ⓪ = OUTLET DATA
STB = SET TOP BOX
⦿ = OUTLET IPTV
DS● = DOOR SENSOR
△ = OUTLET TELEPHONE



REFLECTED CEILING PLAN
3rd FLOOR

<div>OWNER/CLIENT</div> <div></div> <div>s a w i t</div> <div>APPROVED : .../.../...</div> <div><div>..... (name)</div><div>..... (position)</div><div>(signed) (Dep./Div.)</div></div>	<div>PROJECT</div> <div>BPDP</div> <div>KELAPA SAWIT</div> <div>Jl. Medan Merdeka Tim, RT.7/RW.1, Gambir, Kec. Gambir, Kota Jakarta Pusat, Daerah Khusus Ibukota Jakarta 10110</div>	<div>INTERIOR DESIGN CONSULTANT</div> <div>PT. MADEA AGKASAMA</div> <div>Jl. Hati Suci No. 4 Gd. Sakura Lt. 2 Room 201 Kel. Kampung Bali, Kec. Tanah Abang, Jakarta Pusat Telp. 021 - 2303483 , Fax. 021 - 2303483 APPROVED : //</div>	<div>MEP CONSULTANT</div> <div> PT. DUTA PRATAMA ENGINEERING MECHANICAL & ELECTRICAL ENGINEER</div> <div>Rukan Taman Murya Blok M No. 37, J. Batu Mulia No. 1 Murya Utara Kembangan – Jakarta Barat 11620 Phone : 021-5845545, 5845547, 5845555, Fax : 021-58474531 Email : dpeptline@gmail.com, ptidpe.me@yahoo.com</div>	DRAWING TITLE	<div></div>		.../.../...	DRAWN	DRAWING NUMBER
				DENAH INSTALASI ICT LANTAI 3	<div></div>		.../.../...	Denny	EC-404
				SCALE : 1:150	<div></div>		.../.../...	DATE : 15/05/24	
				ALL MEASUREMENT MUST BE CHECKED AT BY SITE BY THE CONTRACTORS AND ANY DIFFERENCES REPORTED/INITIATED TO THE DESIGNER FOR CLARIFICATION BEFORE PROCEEDING.	<div></div>		.../.../...	CHECKED	PAGE
					<div></div>		.../.../...	Widodo	
	#	REVISION :	DATE	DATE : 15/05/24		DRAWING FOR	DATE : 2024/05/10		
								TENDER	