


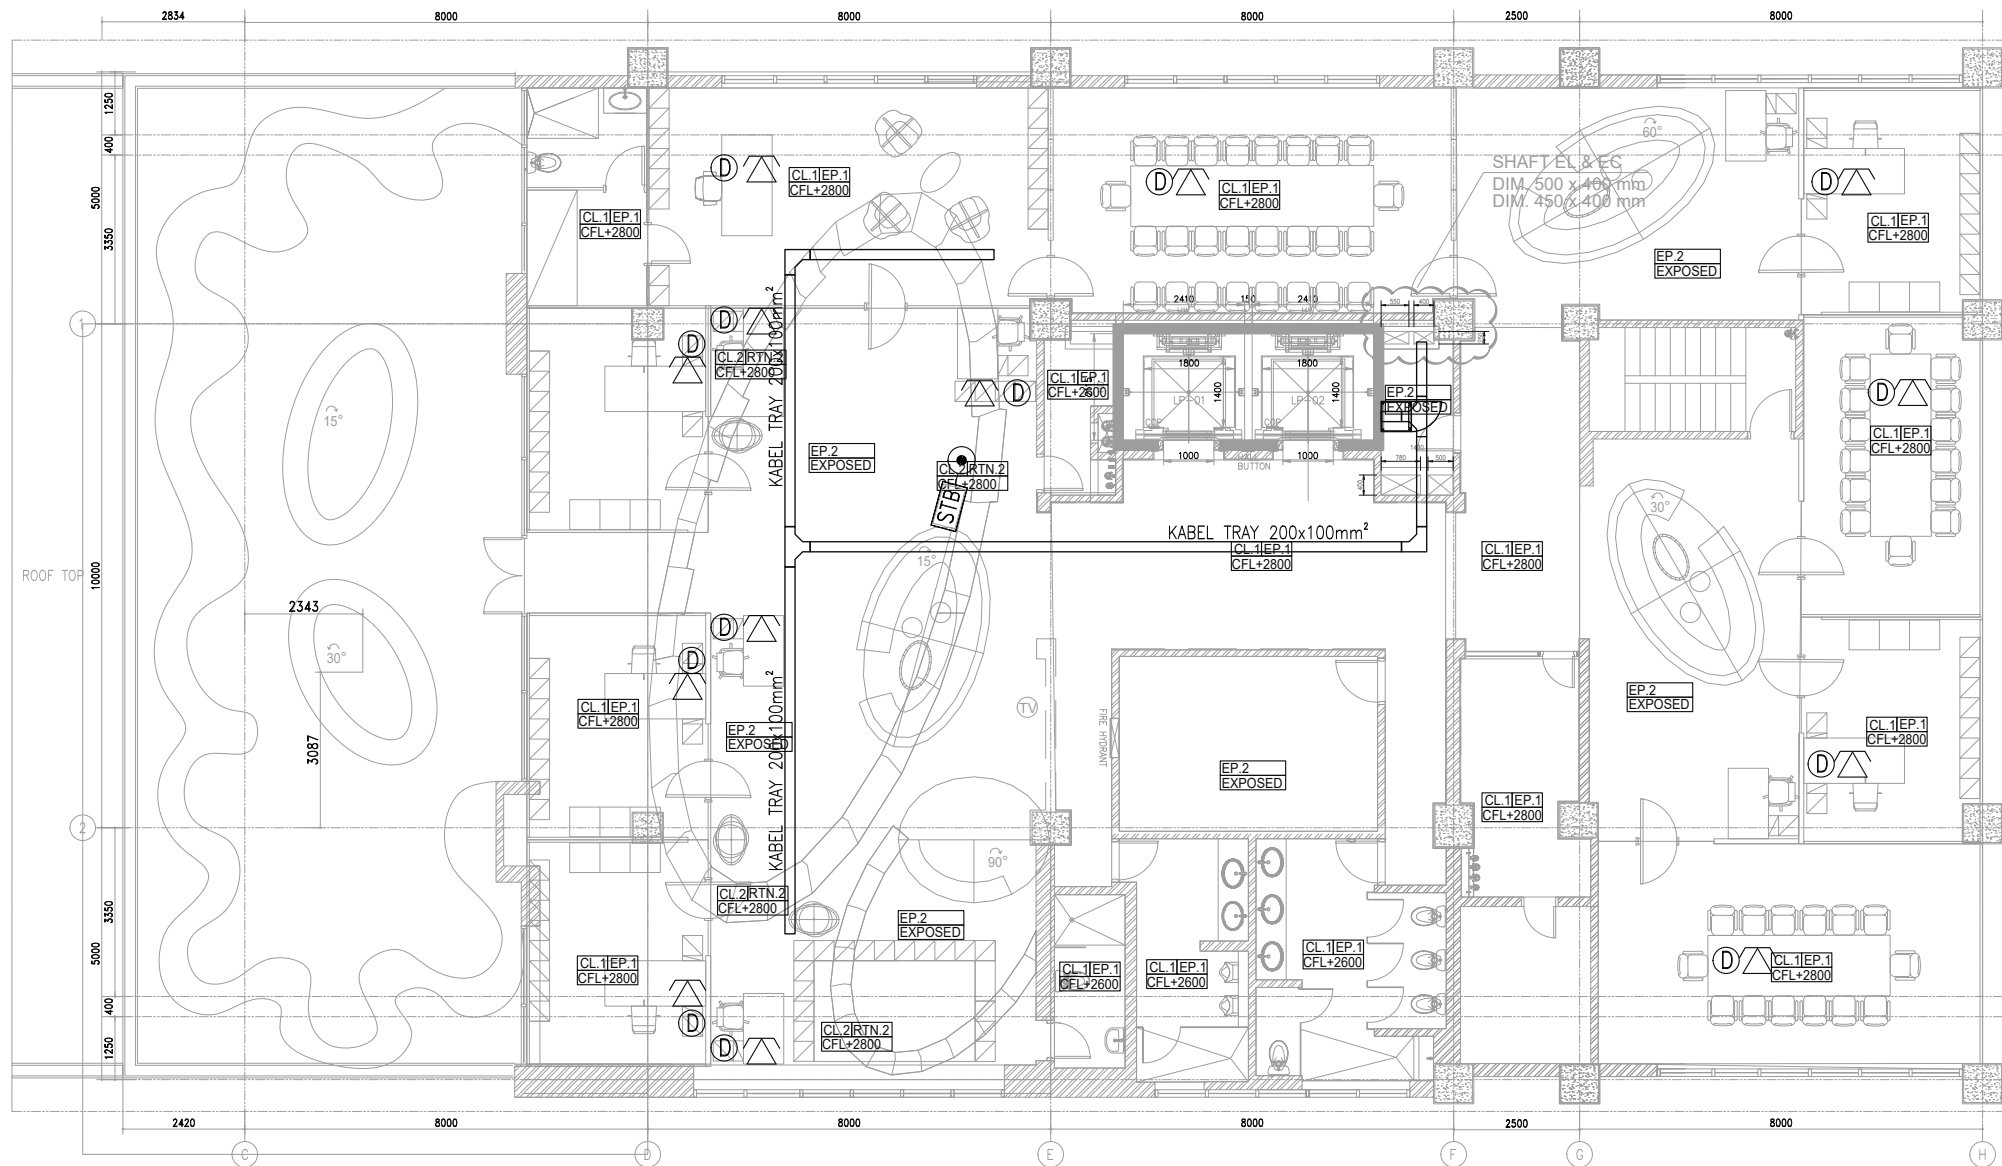

KETERANGAN :

- ① = OUTLET DATA
STB = SET TOP BOX
● = OUTLET IPTV
DS ● = DOOR SENSOR
△ = OUTLET TELEPHONE



REFLECTED CEILING PLAN
3A FLOOR

<div>OWNER/CLIENT</div> <div><div>sawit</div></div> <div>APPROVED : .../.../...</div> <div><div>..... (name)</div><div>..... (position)</div><div>(signed) (Dep./Div.)</div></div>	<div>PROJECT</div> <div><div>BPDP</div><div>KELAPA SAWIT</div></div> <div>Jl.Medan Merdeka Tim, RT.7/RW.1, Gambir, Kec. Gambir, Kota Jakarta Pusat, Daerah Khusus Ibukota Jakarta 10110</div>	<div>INTERIOR DESIGN CONSULTANT</div> <div><div>PT. MADEA AGKASAMA</div><div>Jl. Hati Suci No. 4 Gd. Sakura Lt. 2 Room 201 Kel. Kampung Bali, Kec. Tanah Abang, Jakarta Pusat Telp. 021 - 2303483 , Fax. 021 - 2303483 APPROVED : //</div></div>	<div>MEP CONSULTANT</div> <div><div><div>PT. DUTA PRATAMA ENGINEERING</div><div>MECHANICAL & ELECTRICAL ENGINEER</div></div><div>Rukan Taman Murya Blok M No. 37, J. Batu Mulia No. 1 Murya Utara Kembangan - Jakarta Barat 11620 Phone : 021-5845246, 5845247, 5845246, Fax : 021-58474531 Email : dpeptline@gmail.com, ptidpe.me@yahoo.com</div></div>	<div>DRAWING TITLE</div> <div><div>DENAH INSTALASI ICT LANTAI 3A</div><div>SCALE : 1:150</div><div>ALL MEASUREMENT MUST BE CHECKED AT BY SITE BY THE CONTRACTORS AND ANY DIFFERENCES REPORTED/INITIATED TO THE DESIGNER FOR CLARIFICATION BEFORE PROCEEDING.</div></div>	<div><div><div><div>△</div><div>...</div><div>.../.../...</div></div><div><div>△</div><div>...</div><div>.../.../...</div></div><div><div>△</div><div>...</div><div>.../.../...</div></div><div><div>△</div><div>...</div><div>.../.../...</div></div><div><div>△</div><div>...</div><div>.../.../...</div></div><div><div>#</div><div>REVISION :</div><div>DATE</div></div></div></div>	<div><div>DRAWN Denny DATE : 15/05/24</div><div>CHECKED Widodo DATE : 15/05/24</div><div>DRAWING FOR TENDER</div><div>DRAWING NUMBER EC-405</div><div>PAGE</div><div>DATE : 2024/05/10</div></div>
---	---	--	---	--	--	--