




KETERANGAN :

- ① = OUTLET DATA
STB = SET TOP BOX
● = OUTLET IPTV
DS ● = DOOR SENSOR
△ = OUTLET TELEPHONE

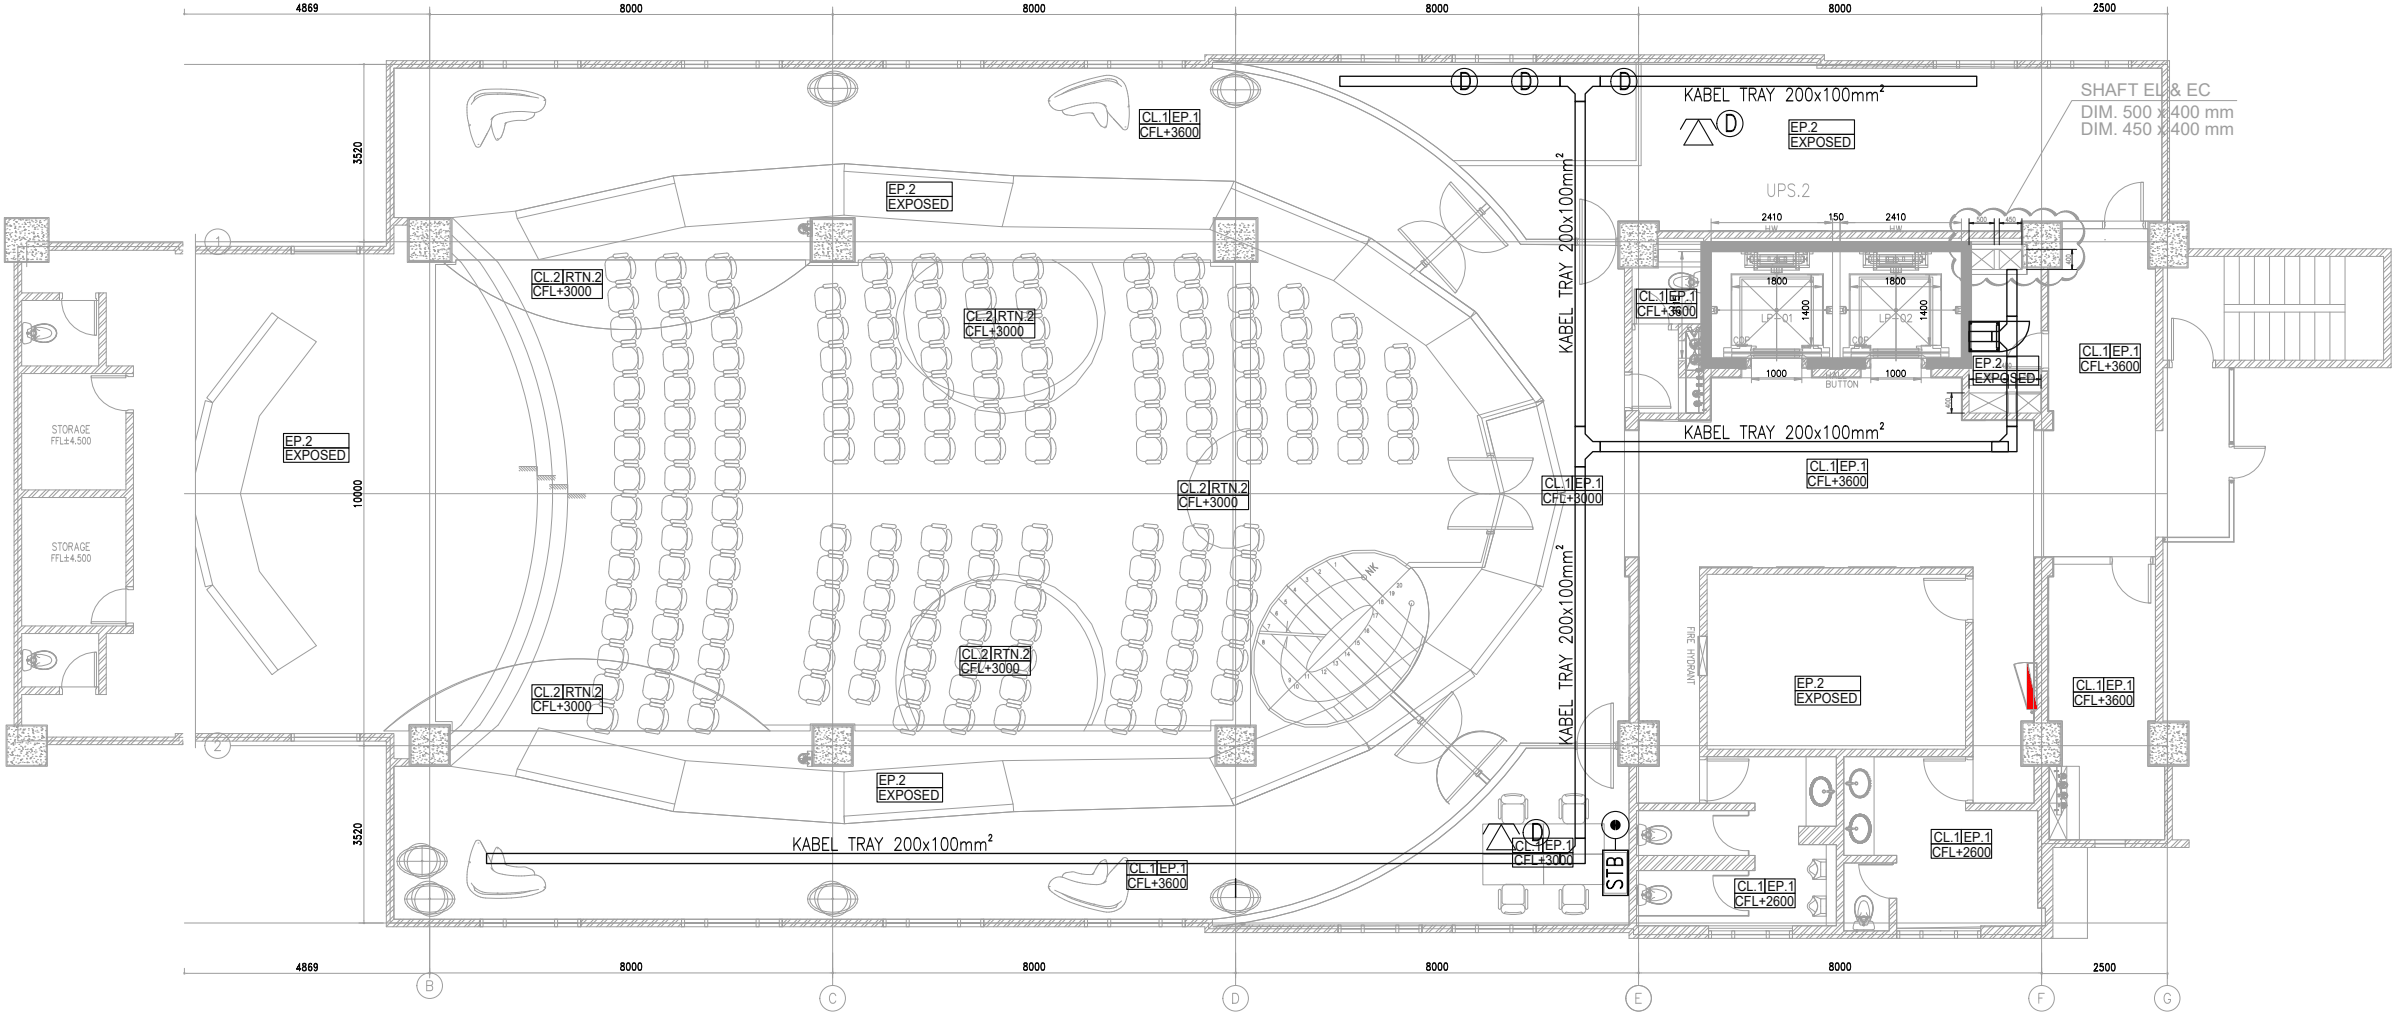

REFLECTED CEILING PLAN
1st FLOOR

<div>OWNER/CLIENT</div> <div></div> <div>APPROVED : .../.../...</div> <div><div>.....(name)</div><div>.....(position)</div><div>(signed).....(Dep./Div.)</div></div>	<div>PROJECT</div> <div>BPDP KELAPA SAWIT</div> <div>Jl.Medan Merdeka Tim, RT.7/RW.1, Gambir, Kec. Gambir, Kota Jakarta Pusat, Daerah Khusus Ibukota Jakarta 10110</div>	<div>INTERIOR DESIGN CONSULTANT</div> <div>PT.MADEA AGKASAMA</div> <div>Jl. Hati Suci No. 4 Gd. Sakura Lt. 2 Room 201 Kel. Kampung Bali, Kec. Tanah Abang, Jakarta Pusat Telp. 021 - 2303483 , Fax. 021 - 2303483 APPROVED : //</div>	<div>MEP CONSULTANT</div> <div>PT.DUTA PRATAMA ENGINEERING MECHANICAL & ELECTRICAL ENGINEER</div> <div>Rukan Taman Murya Blok M No. 37, J. Batu Mulia No. 1 Murya Utara Kembangan – Jakarta Barat 11620 Phone : 021-5845545, 5845547, 5845555, Fax : 021-58474531 Email : dpept.me@gmail.com, pt.dpe.me@yahoo.com</div>	<div>DRAWING TITLE</div> <div>DENAH INSTALASI ICT LANTAI 1</div> <div>SCALE : 1:150</div> <div>ALL MEASUREMENT MUST BE CHECKED AT BY SITE BY THE CONTRACTORS AND ANY DIFFERENCES REPORTED/INITIATED TO THE DESIGNER FOR CLARIFICATION BEFORE PROCEEDING.</div>	<div>△</div> <div>...</div> <div>.../.../...</div>	<div>DRAWN</div> <div>Denny</div> <div>DATE : 15/05/24</div>	<div>DRAWING NUMBER</div> <div>EC-402</div>
					<div>△</div> <div>...</div> <div>.../.../...</div>	<div>CHECKED</div> <div>Widodo</div> <div>DATE : 15/05/24</div>	<div>PAGE</div>
					<div>△</div> <div>...</div> <div>.../.../...</div>	<div>DRAWING FOR</div> <div>TENDER</div>	
					<div>△</div> <div>...</div> <div>.../.../...</div>	<div>DATE : 2024/05/10</div>	
					<div>△</div> <div>...</div> <div>.../.../...</div>		
					<div>#</div> <div>REVISION :</div> <div>DATE</div>		