


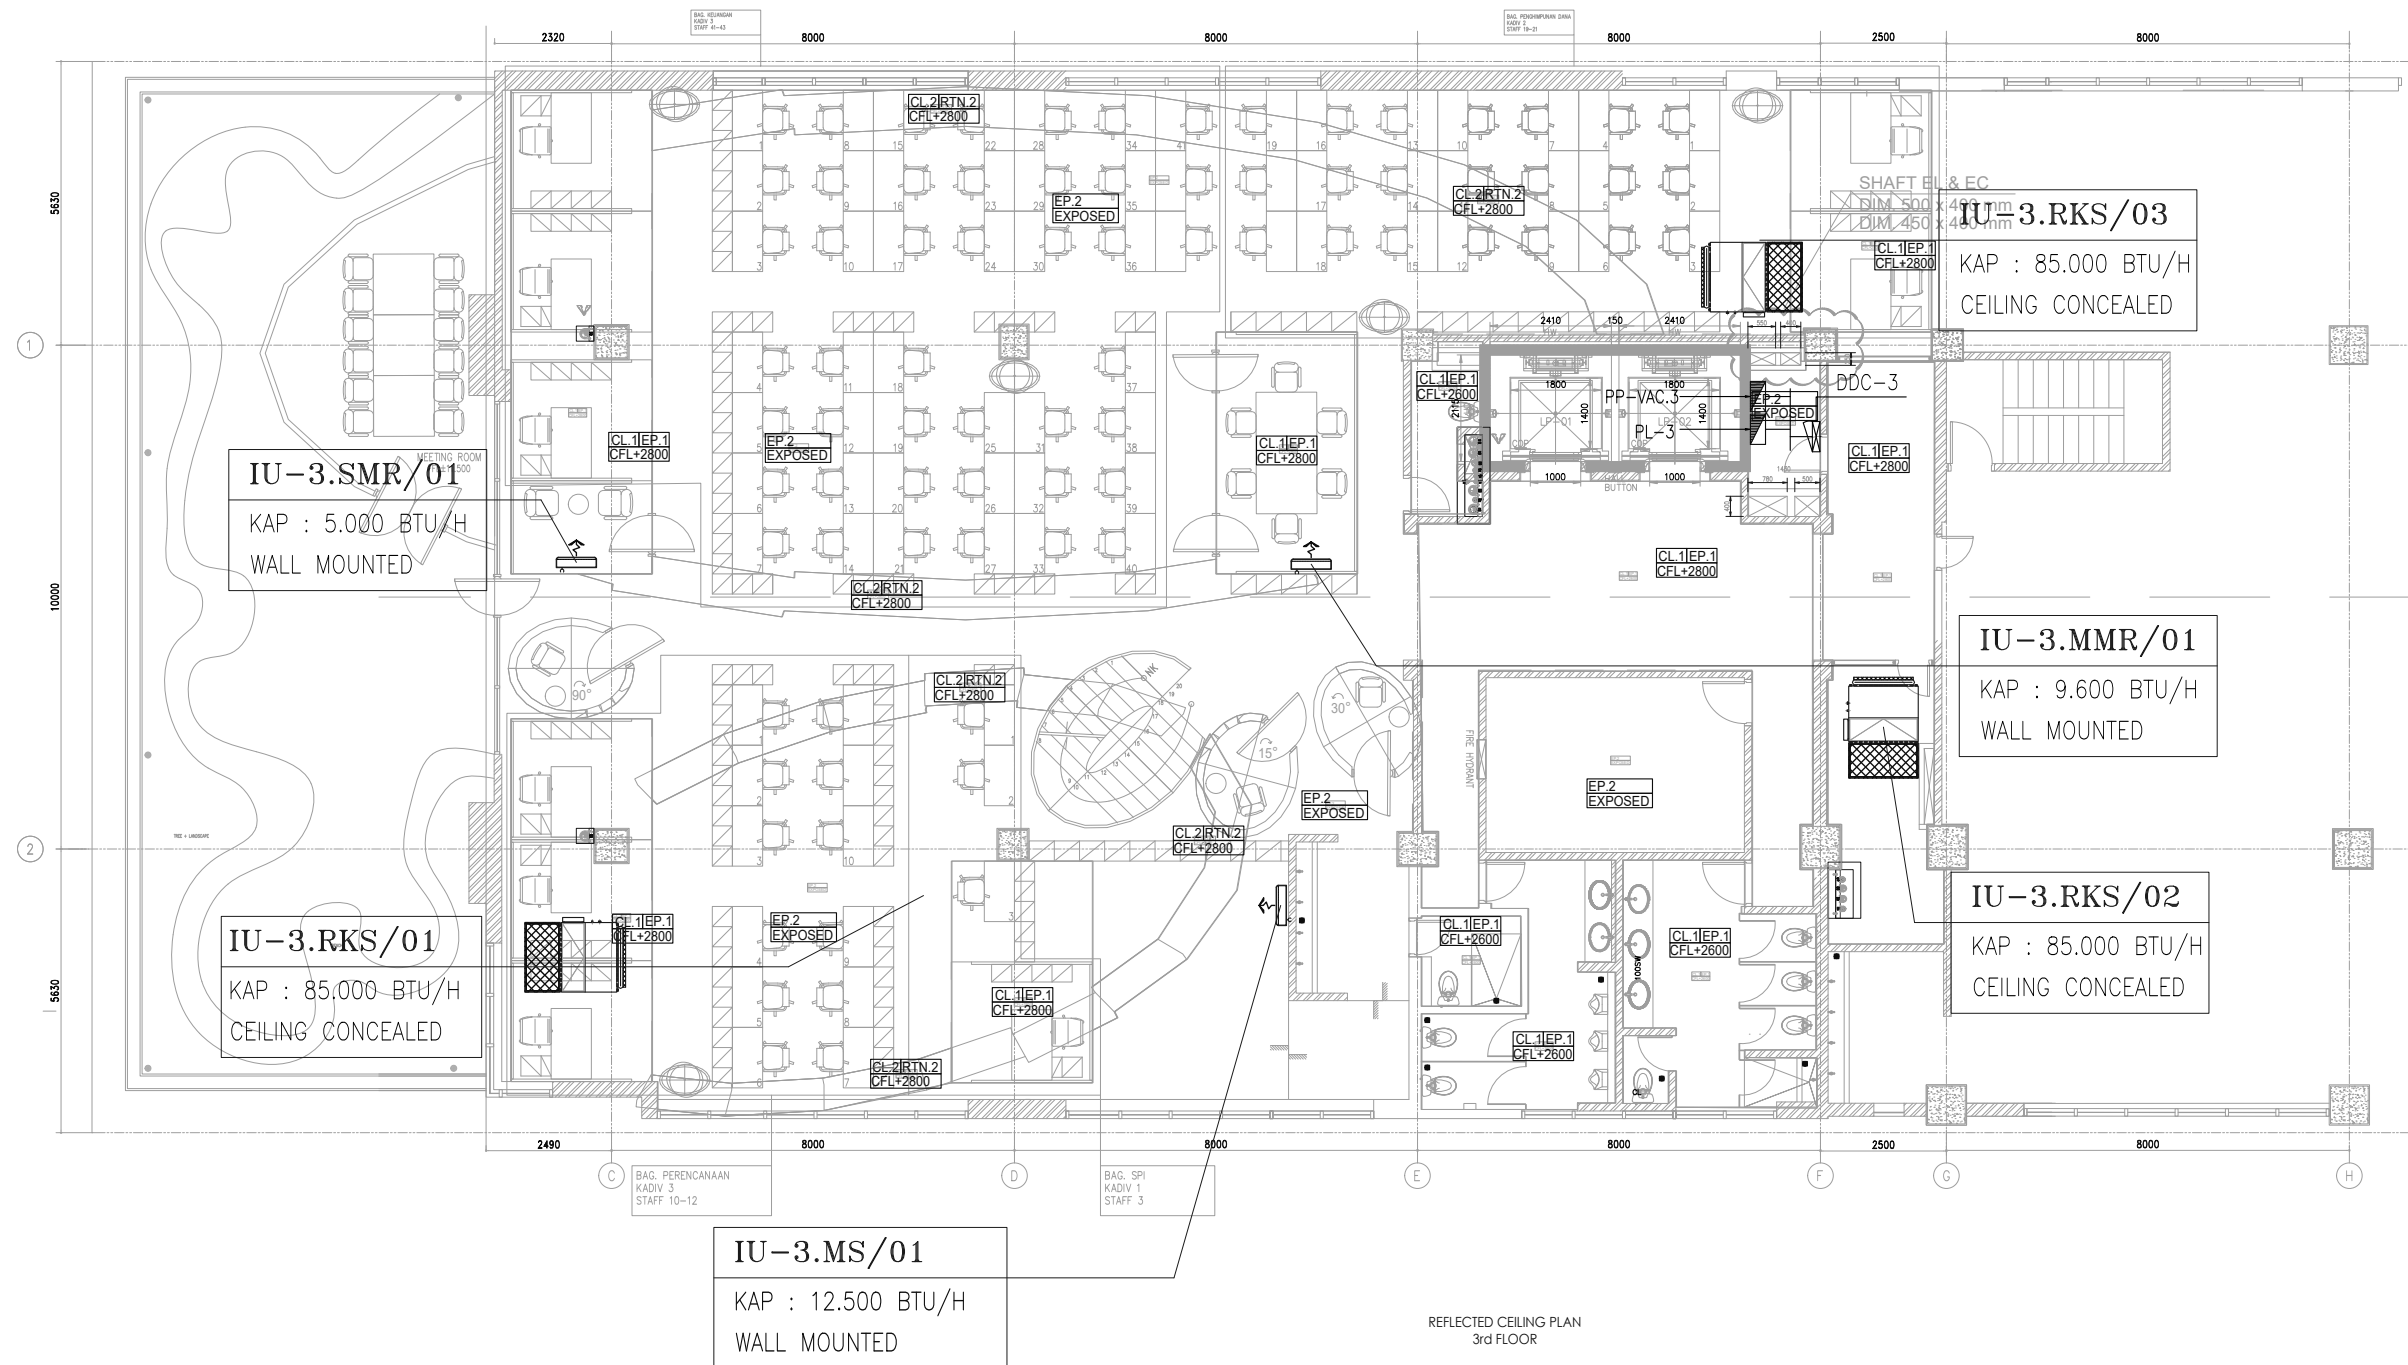






PL	= PANEL PENERANGAN
PP	= PANEL POWER
DP	= DISTRIBUTION PANEL
DDC	= DIGITAL DIRECT CONTROLLER



<div>OWNER/CLIENT</div> <div><div>sawit</div></div> <div>APPROVED : .../.../...</div> <div><div>..... (name)</div><div>..... (position)</div><div>(signed) (Dep./Div.)</div></div>	<div>PROJECT</div> <div><div>BPD KELAPA SAWIT</div><div>JL.Medan Merdeka Tim, RT.7/RW.1, Gambir, Kec. Gambir, Kota Jakarta Pusat, Daerah Khusus Ibukota Jakarta 10110</div></div>	<div>INTERIOR DESIGN CONSULTANT</div> <div><div>PT. IMADEA AGKASAMA</div><div>Jl. Hati Suci No. 4 Gd. Sakura Lt. 2 Room 201 Kel. Kampung Bali, Kec. Tanah Abang, Jakarta Pusat Telp. 021 - 2303483 , Fax. 021 - 2303483</div><div>APPROVED : //</div></div>	<div>MEP CONSULTANT</div> <div><div><div>PT. DUTA PRATAMA ENGINEERING MECHANICAL & ELECTRICAL ENGINEER</div><div>Rukan Taman Menyua Blok M No. 37, J. Batu Mulia No. 1 Menyua Utara Kembangan - Jakarta Barat 11620 Phone : 021-5845040, 5845041, 5845056, Fax : 021-58474531 Email : dpeplme@gmail.com, pldpe.me@yahoo.com</div></div></div>	<div>DRAWING TITLE</div> <div>DENAH INSTALASI BMS LANTAI 3</div> <div>SCALE : 1:150</div> <div>ALL MEASUREMENT MUST BE CHECKED AT BY SITE BY THE CONTRACTORS AND ANY DIFFERENCES REPORTED/INITIATED TO THE DESIGNER FOR CLARIFICATION BEFORE PROCEEDING.</div>	<div></div> <div></div> <div></div> <div></div> <div></div> <div># REVISION :</div>	<div>.../.../...</div> <div>.../.../...</div> <div>.../.../...</div> <div>.../.../...</div> <div>.../.../...</div> <div>DATE</div>	<div>DRAWN</div> <div>Denny</div> <div>DATE : 15/05/24</div> <div>CHECKED</div> <div>Widodo</div> <div>DATE : 15/05/24</div> <div>DRAWING FOR</div>	<div>DRAWING NUMBER</div> <div>EC-604</div> <div>PAGE</div> <div>DRAFTING</div> <div>TENDER</div>
---	---	---	--	--	--	--	---	---