


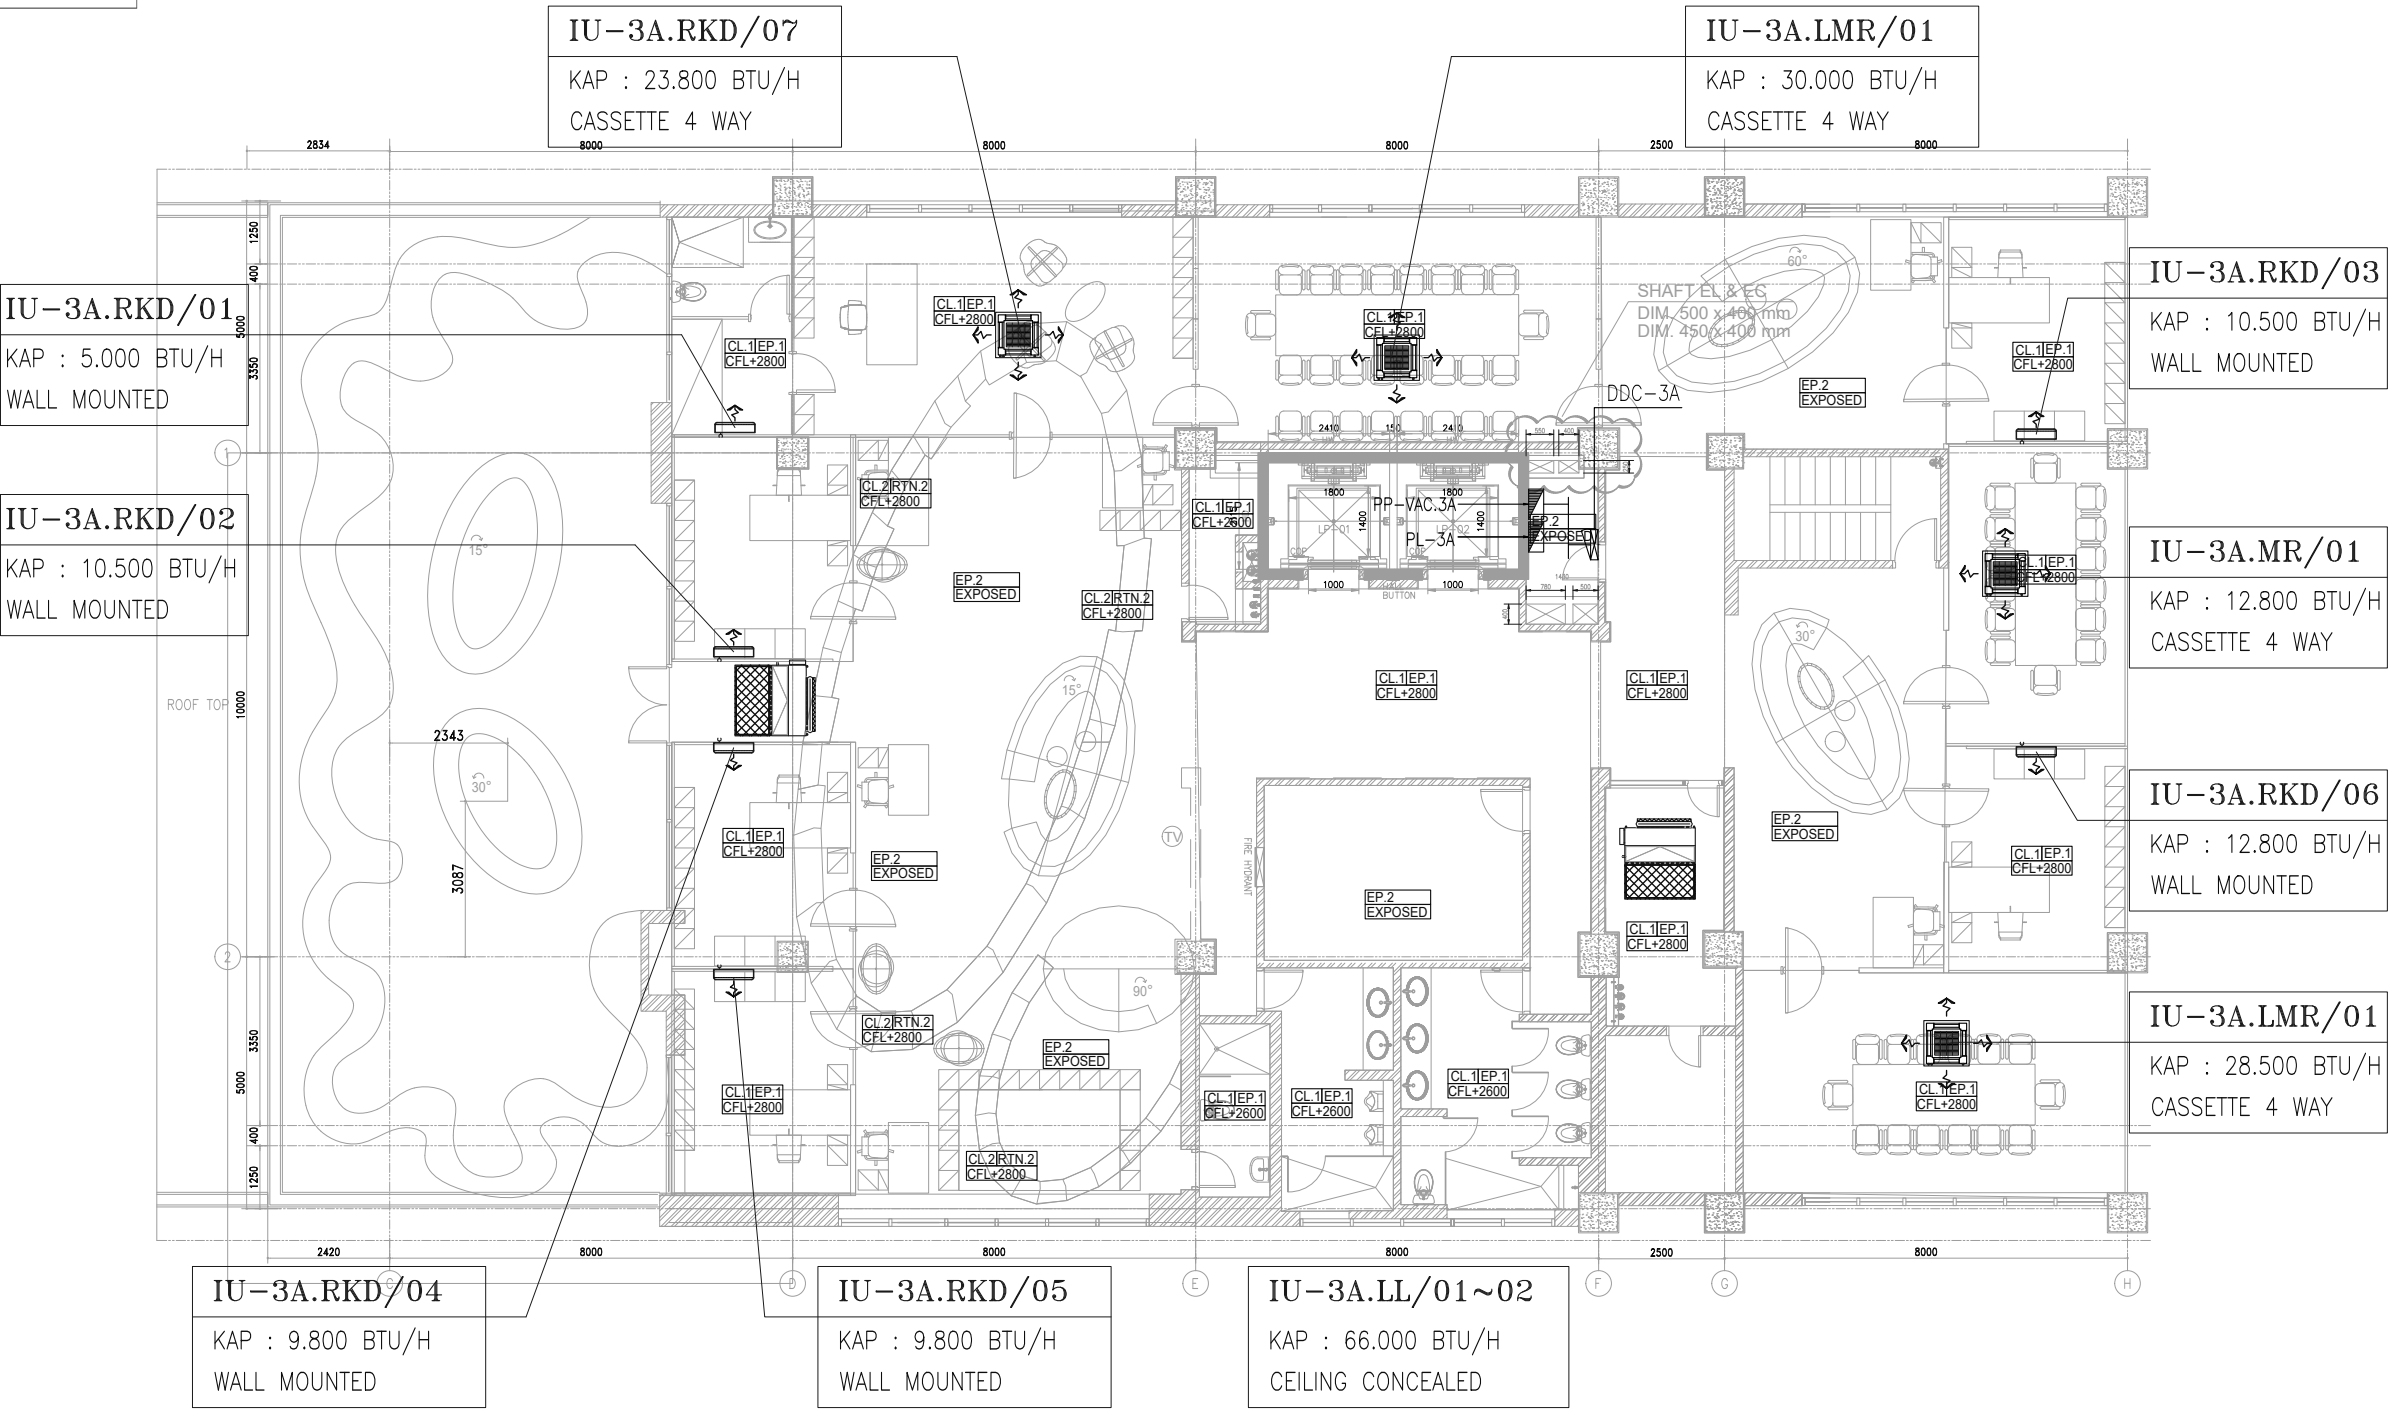







KETERANGAN :

PL	=	PANEL PENERANGAN
PP	=	PANEL POWER
DP	=	DISTRIBUTION PANEL
DDC	=	DIGITAL DIRECT CONTROLLER



REFLECTED CEILING PLAN  
3A FLOOR

<div>OWNER/CLIENT</div> <div></div> <div>APPROVED : .../.../...</div> <div><div>..... (name)</div><div>..... (position)</div><div>..... (Dep./Div.)</div><div>(signed)</div></div>	<div>PROJECT</div> <div>BPDP KELAPA SAWIT</div> <div>Jl.Medan Merdeka Tim, RT.7/RW.1, Gambir, Kec. Gambir, Kota Jakarta Pusat, Daerah Khusus Ibukota Jakarta 10110</div>	<div>INTERIOR DESIGN CONSULTANT</div> <div>PT. <b>MADEA</b> AGKASAMA</div> <div>Jl. Hati Suci No. 4 Gd. Sakura Lt. 2 Room 201 Kel. Kampung Bali, Kec. Tanah Abang, Jakarta Pusat Telp. 021 - 2303483 , Fax. 021 - 2303483 APPROVED : //</div>	<div>MEP CONSULTANT</div> <div></div> <div>PT. <b>DUTA PRATAMA ENGINEERING</b> MECHANICAL &amp; ELECTRICAL ENGINEER</div> <div>Rukan Taman Murya Blok M No. 37, J. Batu Mulia No. 1 Murya Utara Kembangan - Jakarta Barat 11620 Phone : 021-5845546, 5845547, 5845556, Fax : 021-58474531 Email : dpeptline@gmail.com, ptidpe.me@yahoo.com</div>	DRAWING TITLE	<div></div>	.../.../...	DRAWN	DRAWING NUMBER
				DENAH INSTALASI BMS LANTAI 3A	<div></div>	.../.../...	Denny	EC-605
					<div></div>	.../.../...	DATE : 15/05/24	
					<div></div>	.../.../...	CHECKED	PAGE
					SCALE : 1:150	<div></div>	.../.../...	Widodo
				ALL MEASUREMENT MUST BE CHECKED AT BY SITE BY THE CONTRACTORS AND ANY DIFFERENCES REPORTED/INITIATED TO THE DESIGNER FOR CLARIFICATION BEFORE PROCEEDING.	<div></div>	.../.../...	DATE : 15/05/24	
	#	REVISION :	DATE	DRAWING FOR		TENDER		
						DATE : 2024/05/10		