


KETERANGAN :	
PL	= PANEL PENERANGAN
PP	= PANEL POWER
DP	= DISTRIBUTION PANEL
DDC	= DIGITAL DIRECT CONTROLLER

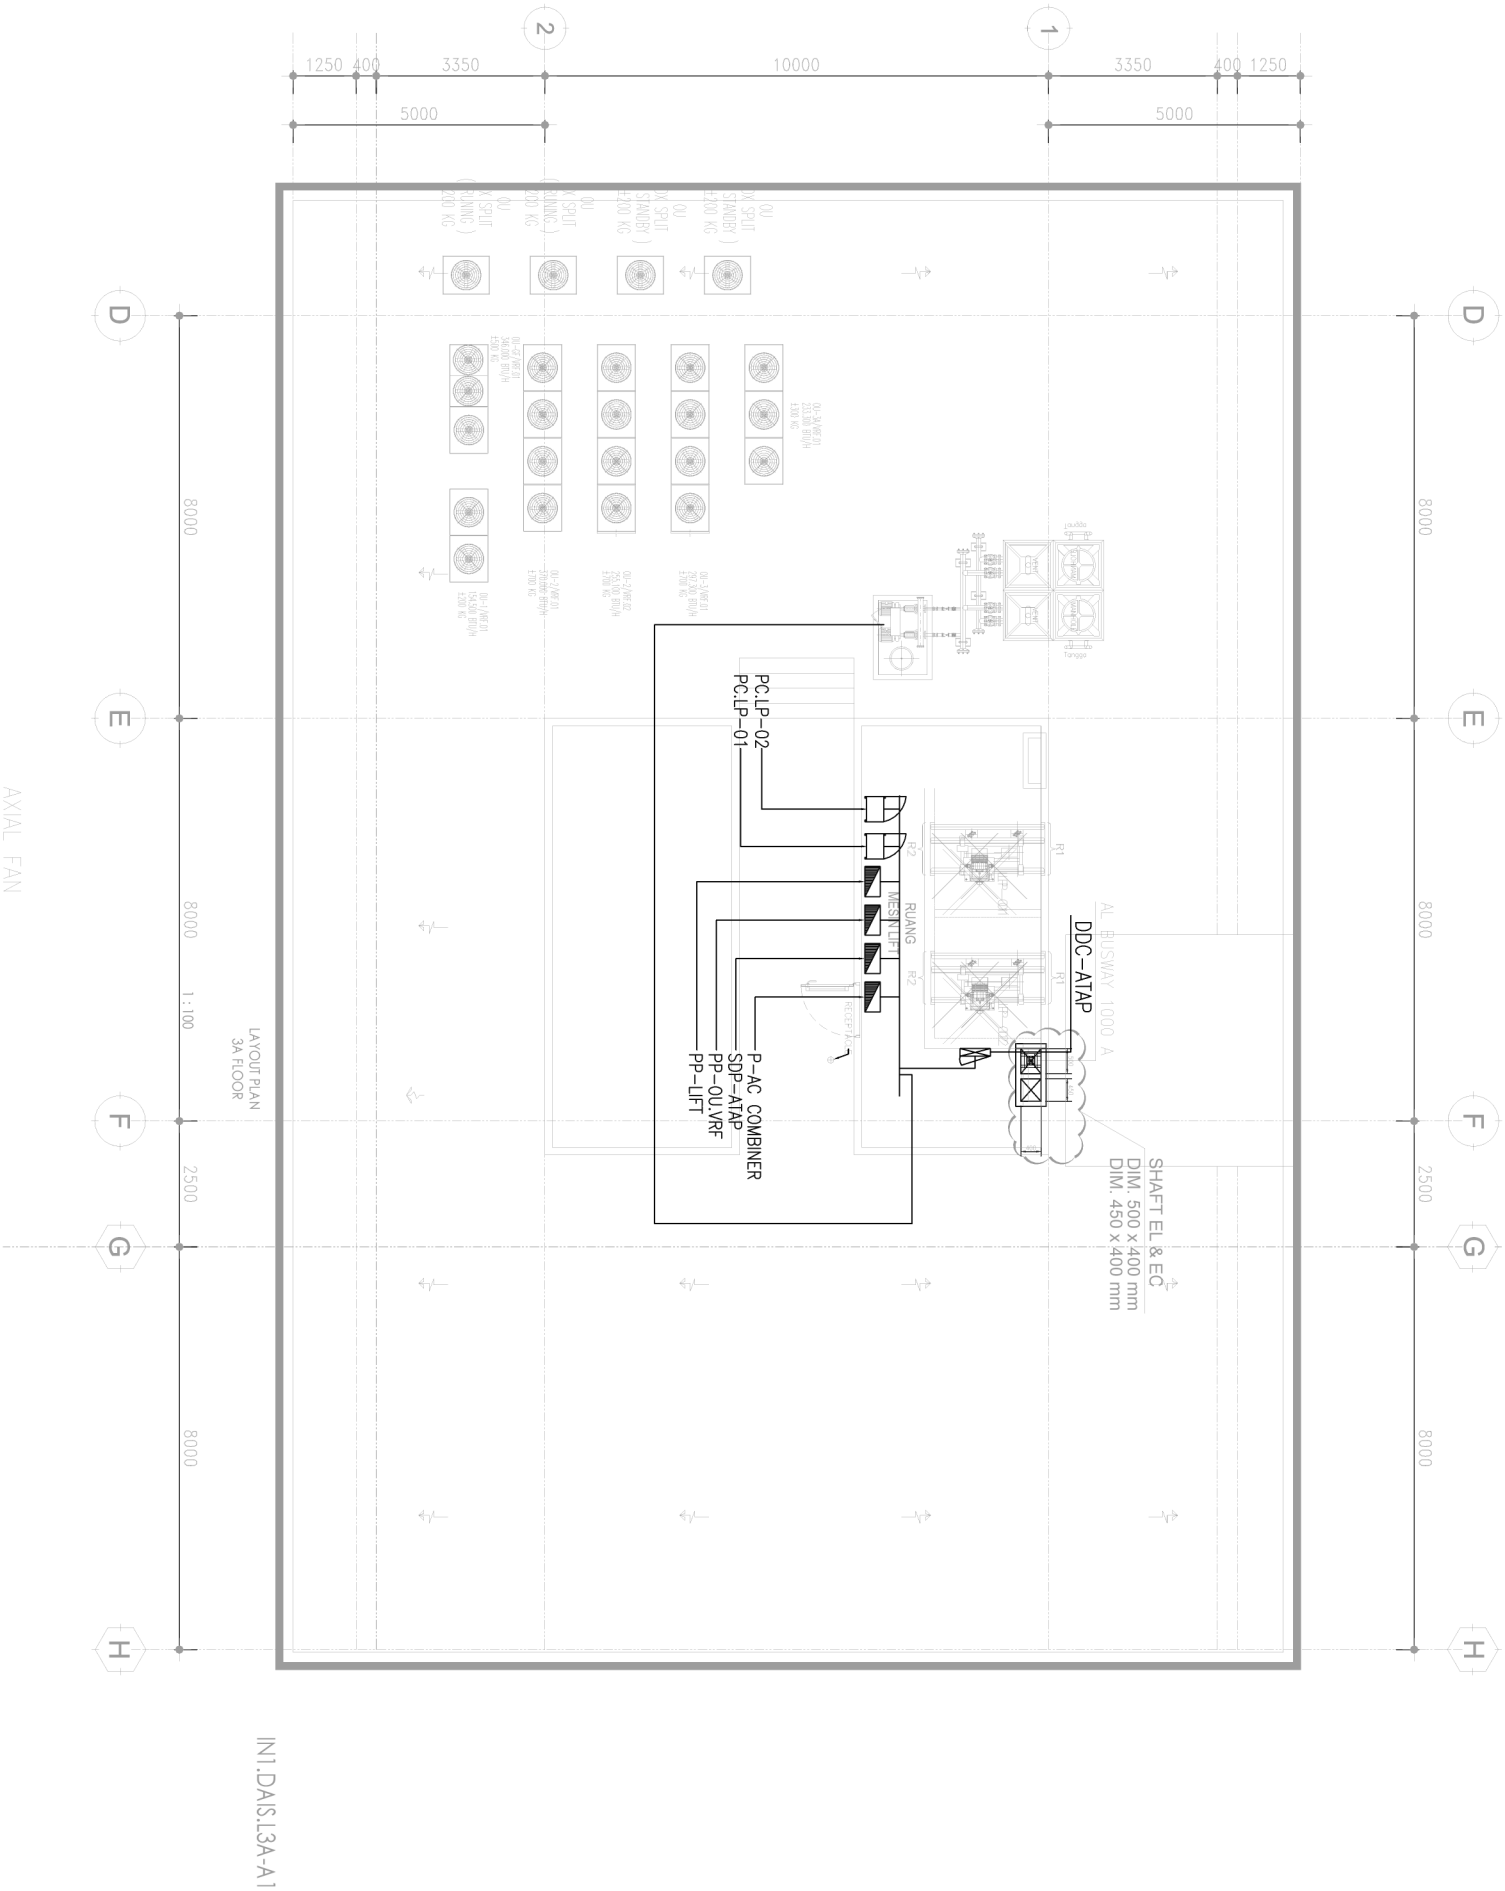

05

DENAH LANTAI ATAP

SCALE 1 : 150

OWNER/CLIENT	PROJECT	INTERIOR DESIGN CONSULTANT	MEP CONSULTANT	DRAWING TITLE		REVISION :		DRAWN	DRAWING NUMBER
<div><div><div></div><div></div><div></div><div></div></div><div>s a w i t</div></div> <div>APPROVED : .../.../...</div> <div>..... (name) (position) (Dep./Div.)</div>	BPPD KELAPA SAWIT Jl. Medan Merdeka Tim, RT/7/Rw.1, Gambir, Kec. Gambir, Kota Jakarta Pusat, Daerah Khusus Ibukota Jakarta 10110	PT. MADEA MAGKASAMA Jl. Heli Sutir No. 4 Gd. Sekura Lt. 2 Room 201 Kel. Kampung Baru, Kec. Tanah Abang, Jakarta Pusat Telp. 021-2303483, Fax 021-2303483 APPROVED : //	<div><div><div></div><div></div><div></div><div></div></div><div>PT. DURA PROTEKTA ENGINEERING</div></div> <div>MECHANICAL & ELECTRICAL ENGINEER Ruko Tugu Mandiri Blok A No. 37, Jl. Bukit Melia No. 1 Kec. Kuning Jaya, Kota Bekasi, Jawa Barat 17122 Telp. 021-84474331 Email : dpept@ptduraprotekta.com, ptpept@ptduraprotekta.com</div>	DENAH INSTALASI BMS LANTAI ATAP		SCALE : 1:150		Denny DATE : 15/05/24	EC-606
				ALL MEASUREMENT MUST BE CHECKED AT BY SITE BY THE CONTRACTORS AND ANY DIFFERENCES REPORTED/NOTIFIED TO THE DESIGNER FOR CLARIFICATION BEFORE PROCEEDING.		Widodo DATE : 15/05/24		DRAWING FOR	
								TENDER	
								DATE : 2024/05/10	